


RAY OWEN OVAL REDEVELOPMENT

96 GLADYS ROAD, LESMURDIE, WA.

DRAWING SCHEDULE:

- SE_11694_F000 COVER SHEET AND DRAWING SCHEDULE
- SE_11694_F010 GENERAL NOTES AND LEGEND
- SE_11694_F100 SITE CLEARING LAYOUT PLAN
- SE_11694_F150 BULK EARTHWORKS LAYOUT PLAN
- SE_11694_F200 GENERAL ARRANGEMENT LAYOUT PLAN
- SE_11694_F250 SITE SECTIONS - SHEET 1 OF 2
- SE_11694_F251 SITE SECTIONS - SHEET 2 OF 2
- SE_11694_F300 STORMWATER DRAINAGE LAYOUT PLAN
- SE_11694_F320 STORMWATER DRAINAGE DETAILS AND PIT SCHEDULE
- SE_11694_F350 STORMWATER DRAINAGE LONG SECTIONS - SHEET 1 OF 3
- SE_11694_F351 STORMWATER DRAINAGE LONG SECTIONS - SHEET 2 OF 3
- SE_11694_F352 STORMWATER DRAINAGE LONG SECTIONS - SHEET 3 OF 3
- SE_11694_F500 IRRIGATION LAYOUT PLAN
- SE_11694_F525 IRRIGATION NOTES LEGEND AND SCHEDULE
- SE_11694_F550 IRRIGATION DETAILS
- SE_11694_F650 PAVEMENT PROFILES AND DETAILS
- SE_11694_F700 1.05m HIGH FENCE DETAILS
- SE_11694_F701 4.0m HIGH FENCE DETAILS
- SE_11694_F702 6.0m HIGH BEHIND GOAL NETTING DETAILS

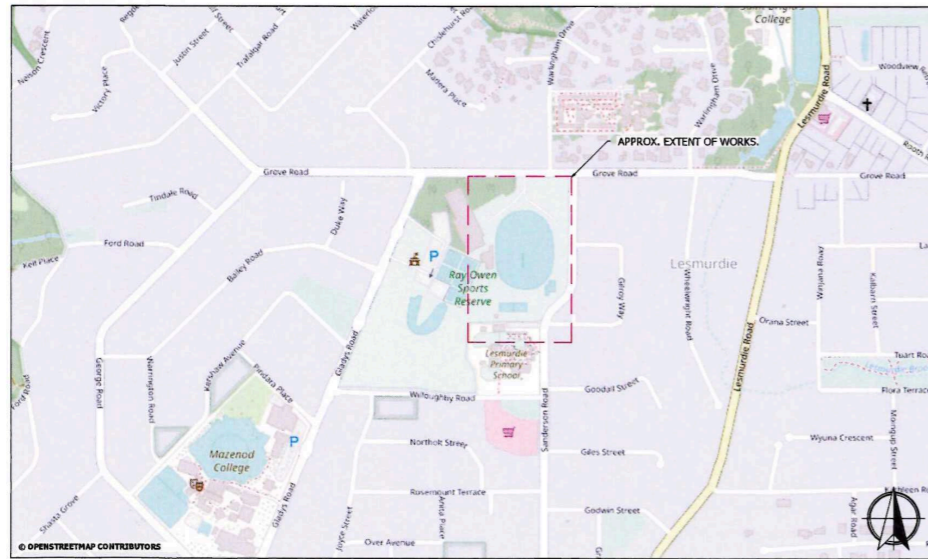


LOCALITY PLAN - 96 GLADYS ROAD, LESMURDIE, WA, 6076.



OVERALL SITE LAYOUT PLAN
ALL AERIAL IMAGERY USED IN THE PRODUCTION OF THIS DRAWING SET HAVE BEEN UNDER LICENSE FROM METROMAP.

NOT FOR CONSTRUCTION

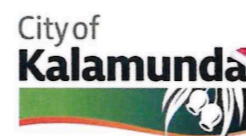

Issue	Date	By	Chkd	Appd	Description
P3	05/04/24	RKC	BGC	JDH	PRELIMINARY ISSUE
P2	31/01/24	RKC	BGC	JDH	PRELIMINARY ISSUE
P1	13/12/23	RKC	BGC	JDH	PRELIMINARY ISSUE

Job Title
RAY OWEN OVAL
REDEVELOPMENT


Drawing Title
COVER SHEET
AND DRAWING SCHEDULE

Discipline
FIELD OF PLAY
Drawing Status
PRELIMINARY
Drawing Number
SE_11694_F000

Issue
P3

PLOT DATE: 05/04/2024 PLOT TIME: 4:56 PM FILE PATH: C:\11694\Kalam\SPORTENG\11694 Ray Owen Oval Redevelopment_231703 Project Data\Drawings\Sheets\SE_11694_F000.dwg

© SPORTENG

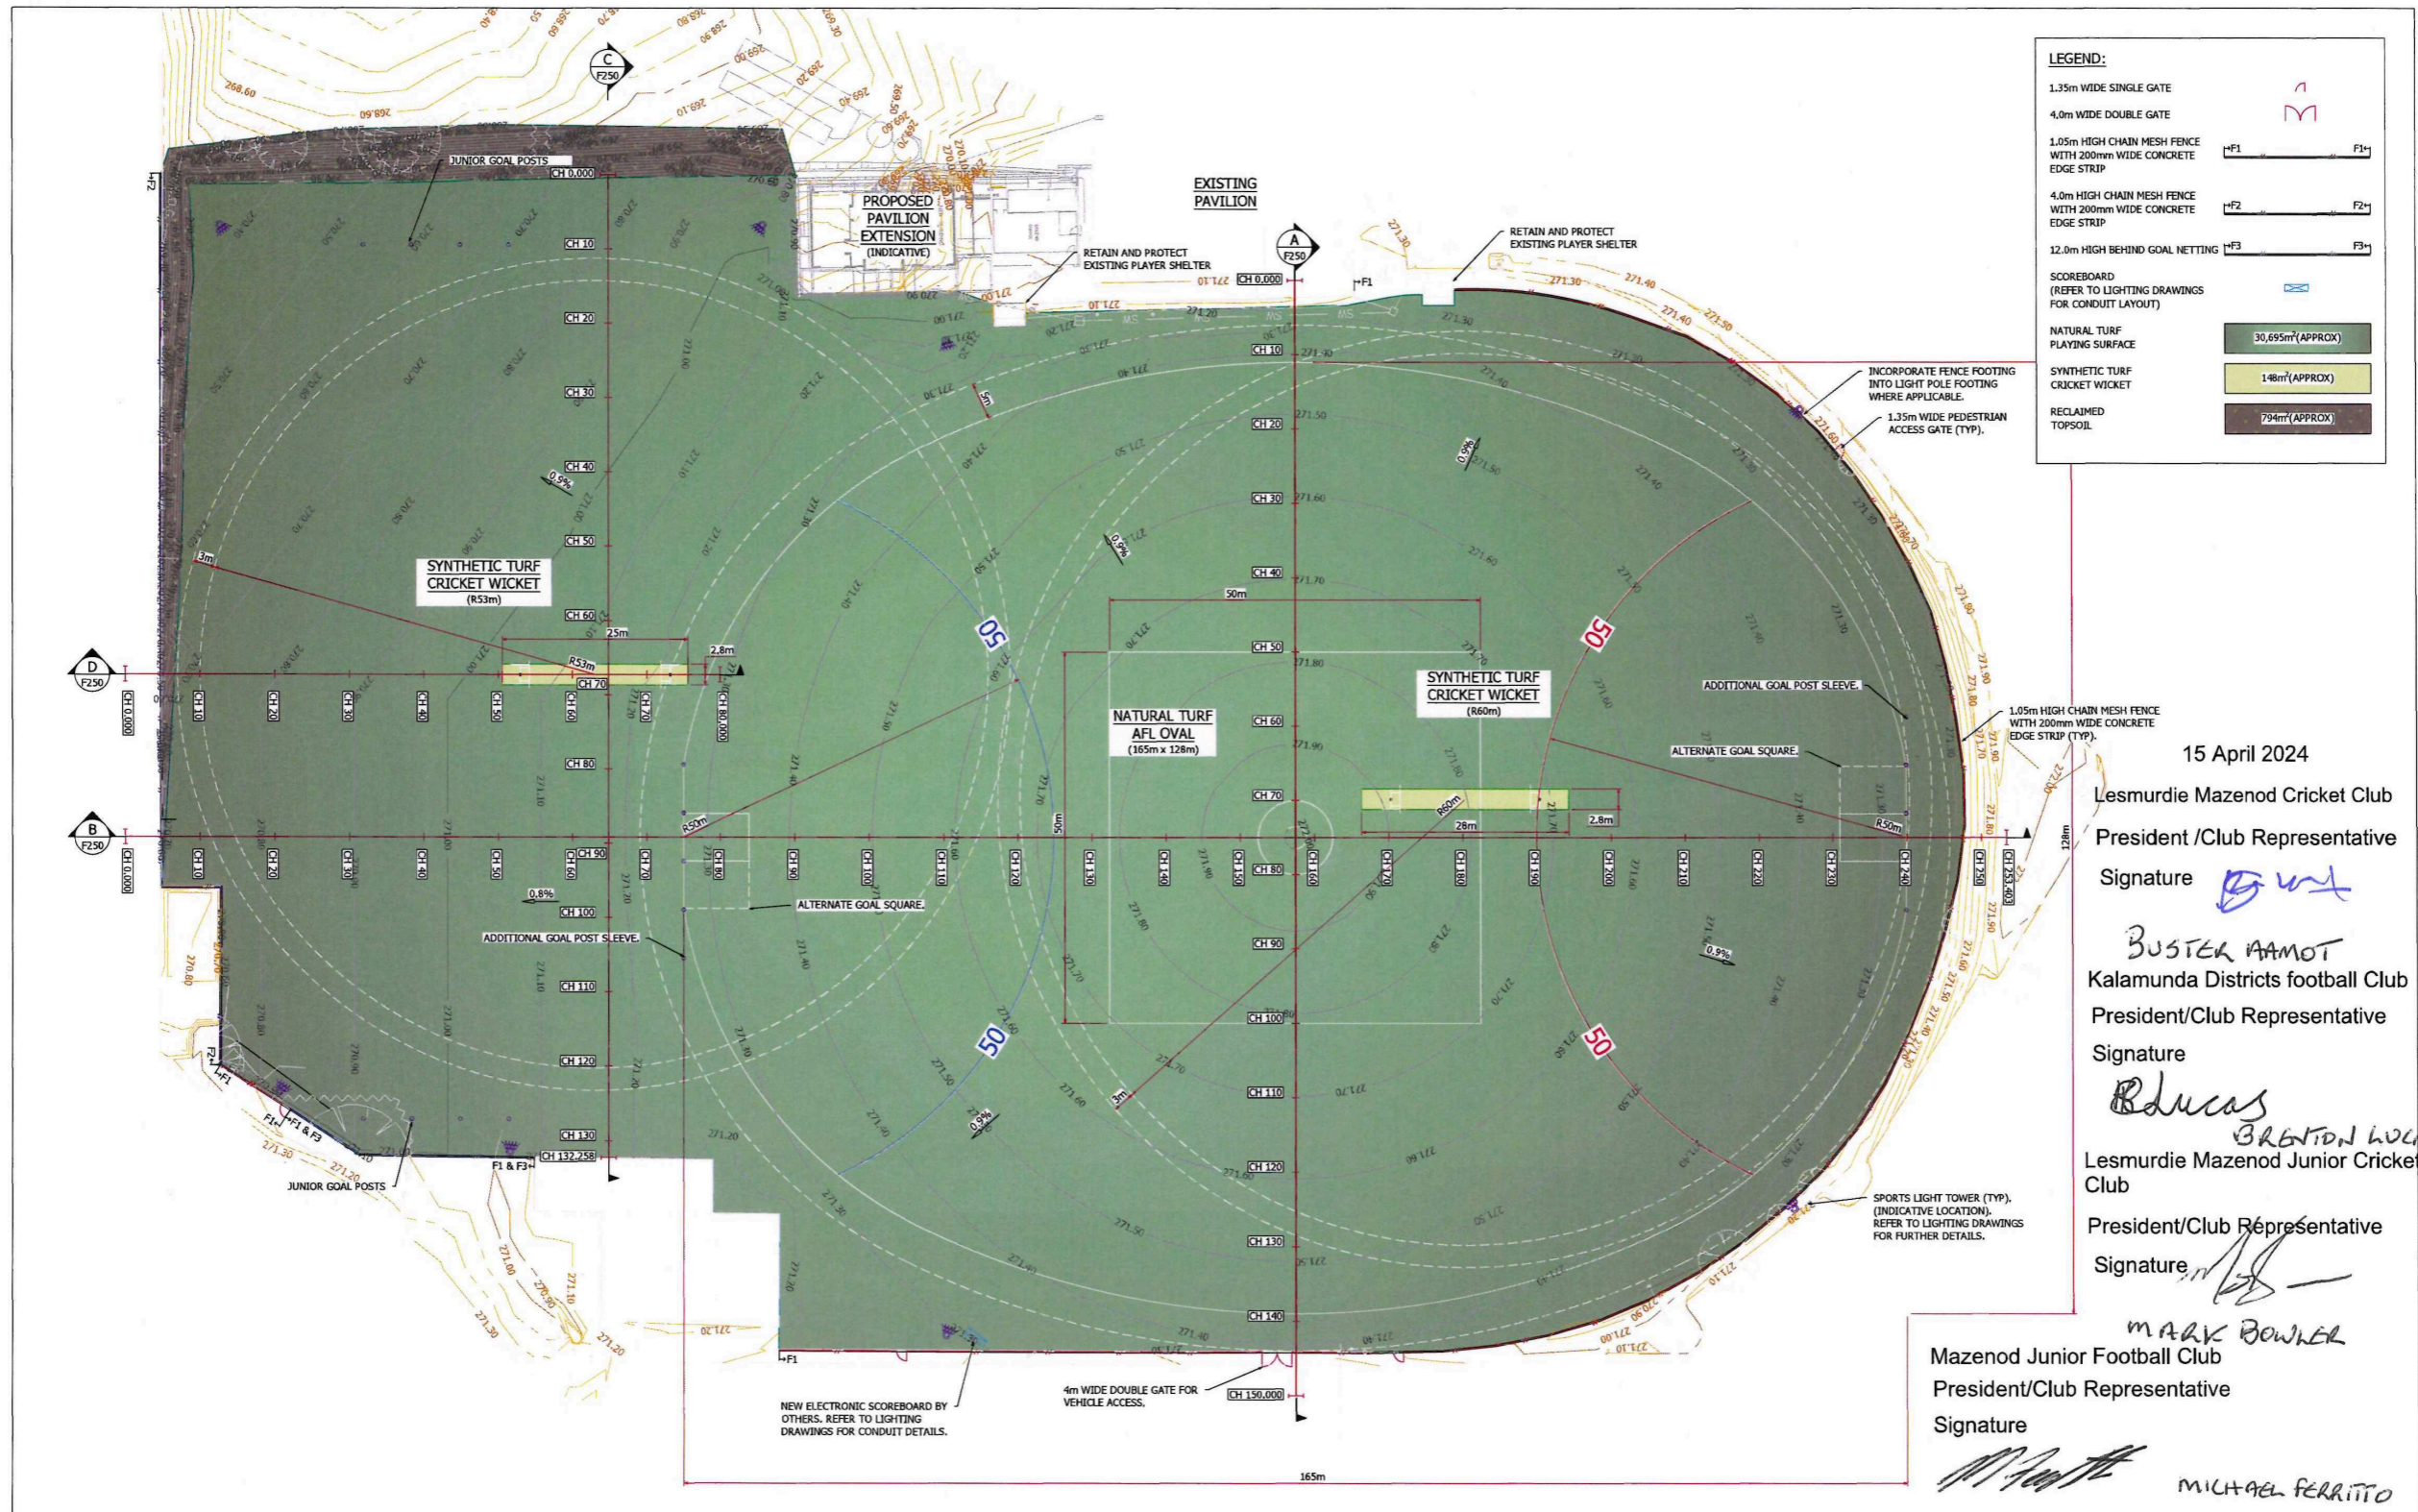

WARNING
BEWARE OF UNDERGROUND SERVICES
THE LOCATION OF UNDERGROUND SERVICES ARE APPROXIMATE ONLY. IT IS THE RESPONSIBILITY OF THE CONTRACTOR TO PROVE THEIR EXACT POSITION ON SITE. NO GUARANTEE IS GIVEN THAT ALL EXISTING SERVICES ARE SHOWN.

NOT FOR CONSTRUCTION



Job Title	RAY OWEN OVAL REDEVELOPMENT		
Drawing Title	GENERAL ARRANGEMENT LAYOUT PLAN		
Issue	Date	By	Appd / Description
P3	05/04/24	RKC BGC JDH	PRELIMINARY ISSUE
P2	31/01/24	RKC BGC JDH	PRELIMINARY ISSUE
P1	13/12/23	RKC BGC JDH	PRELIMINARY ISSUE

PLOT DATE: 05/04/2024 PLOT TIME: 4:52 PM FILE PATH: C:\12165\Map\SPORTENG\11694 Ray Owen Oval Redevelopment_221703 Project Data\Drawings\Sheet\SE_11694_F200.dwg